


EXISTING
CONDITIONS
SURVEY

Building Survey Company:

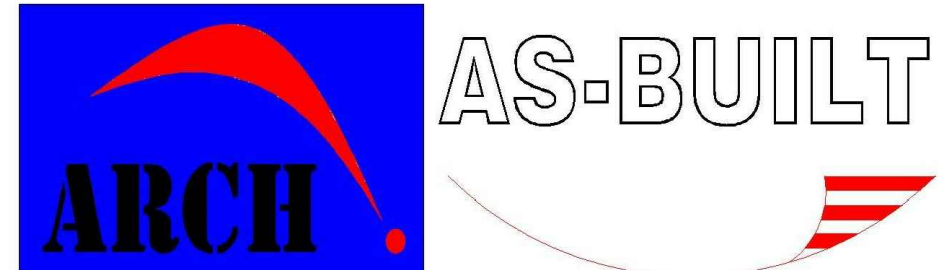

Survey & CAD Designing
Tel: 917.400.3011
Email: archasbuilt@gmail.com
www.archasbuilt.com




Existing Fire Sprinkler System

Client:
ACTIVE FIRE PROTECTION
INC.

26 Ruzhin Road, #301, Monroe NY 10950
Tel: 845.782.7494 Fax: 845.782.7495

www.afpfiresprinkler.com


100 Middlesex Ave Carteret NJ 07008

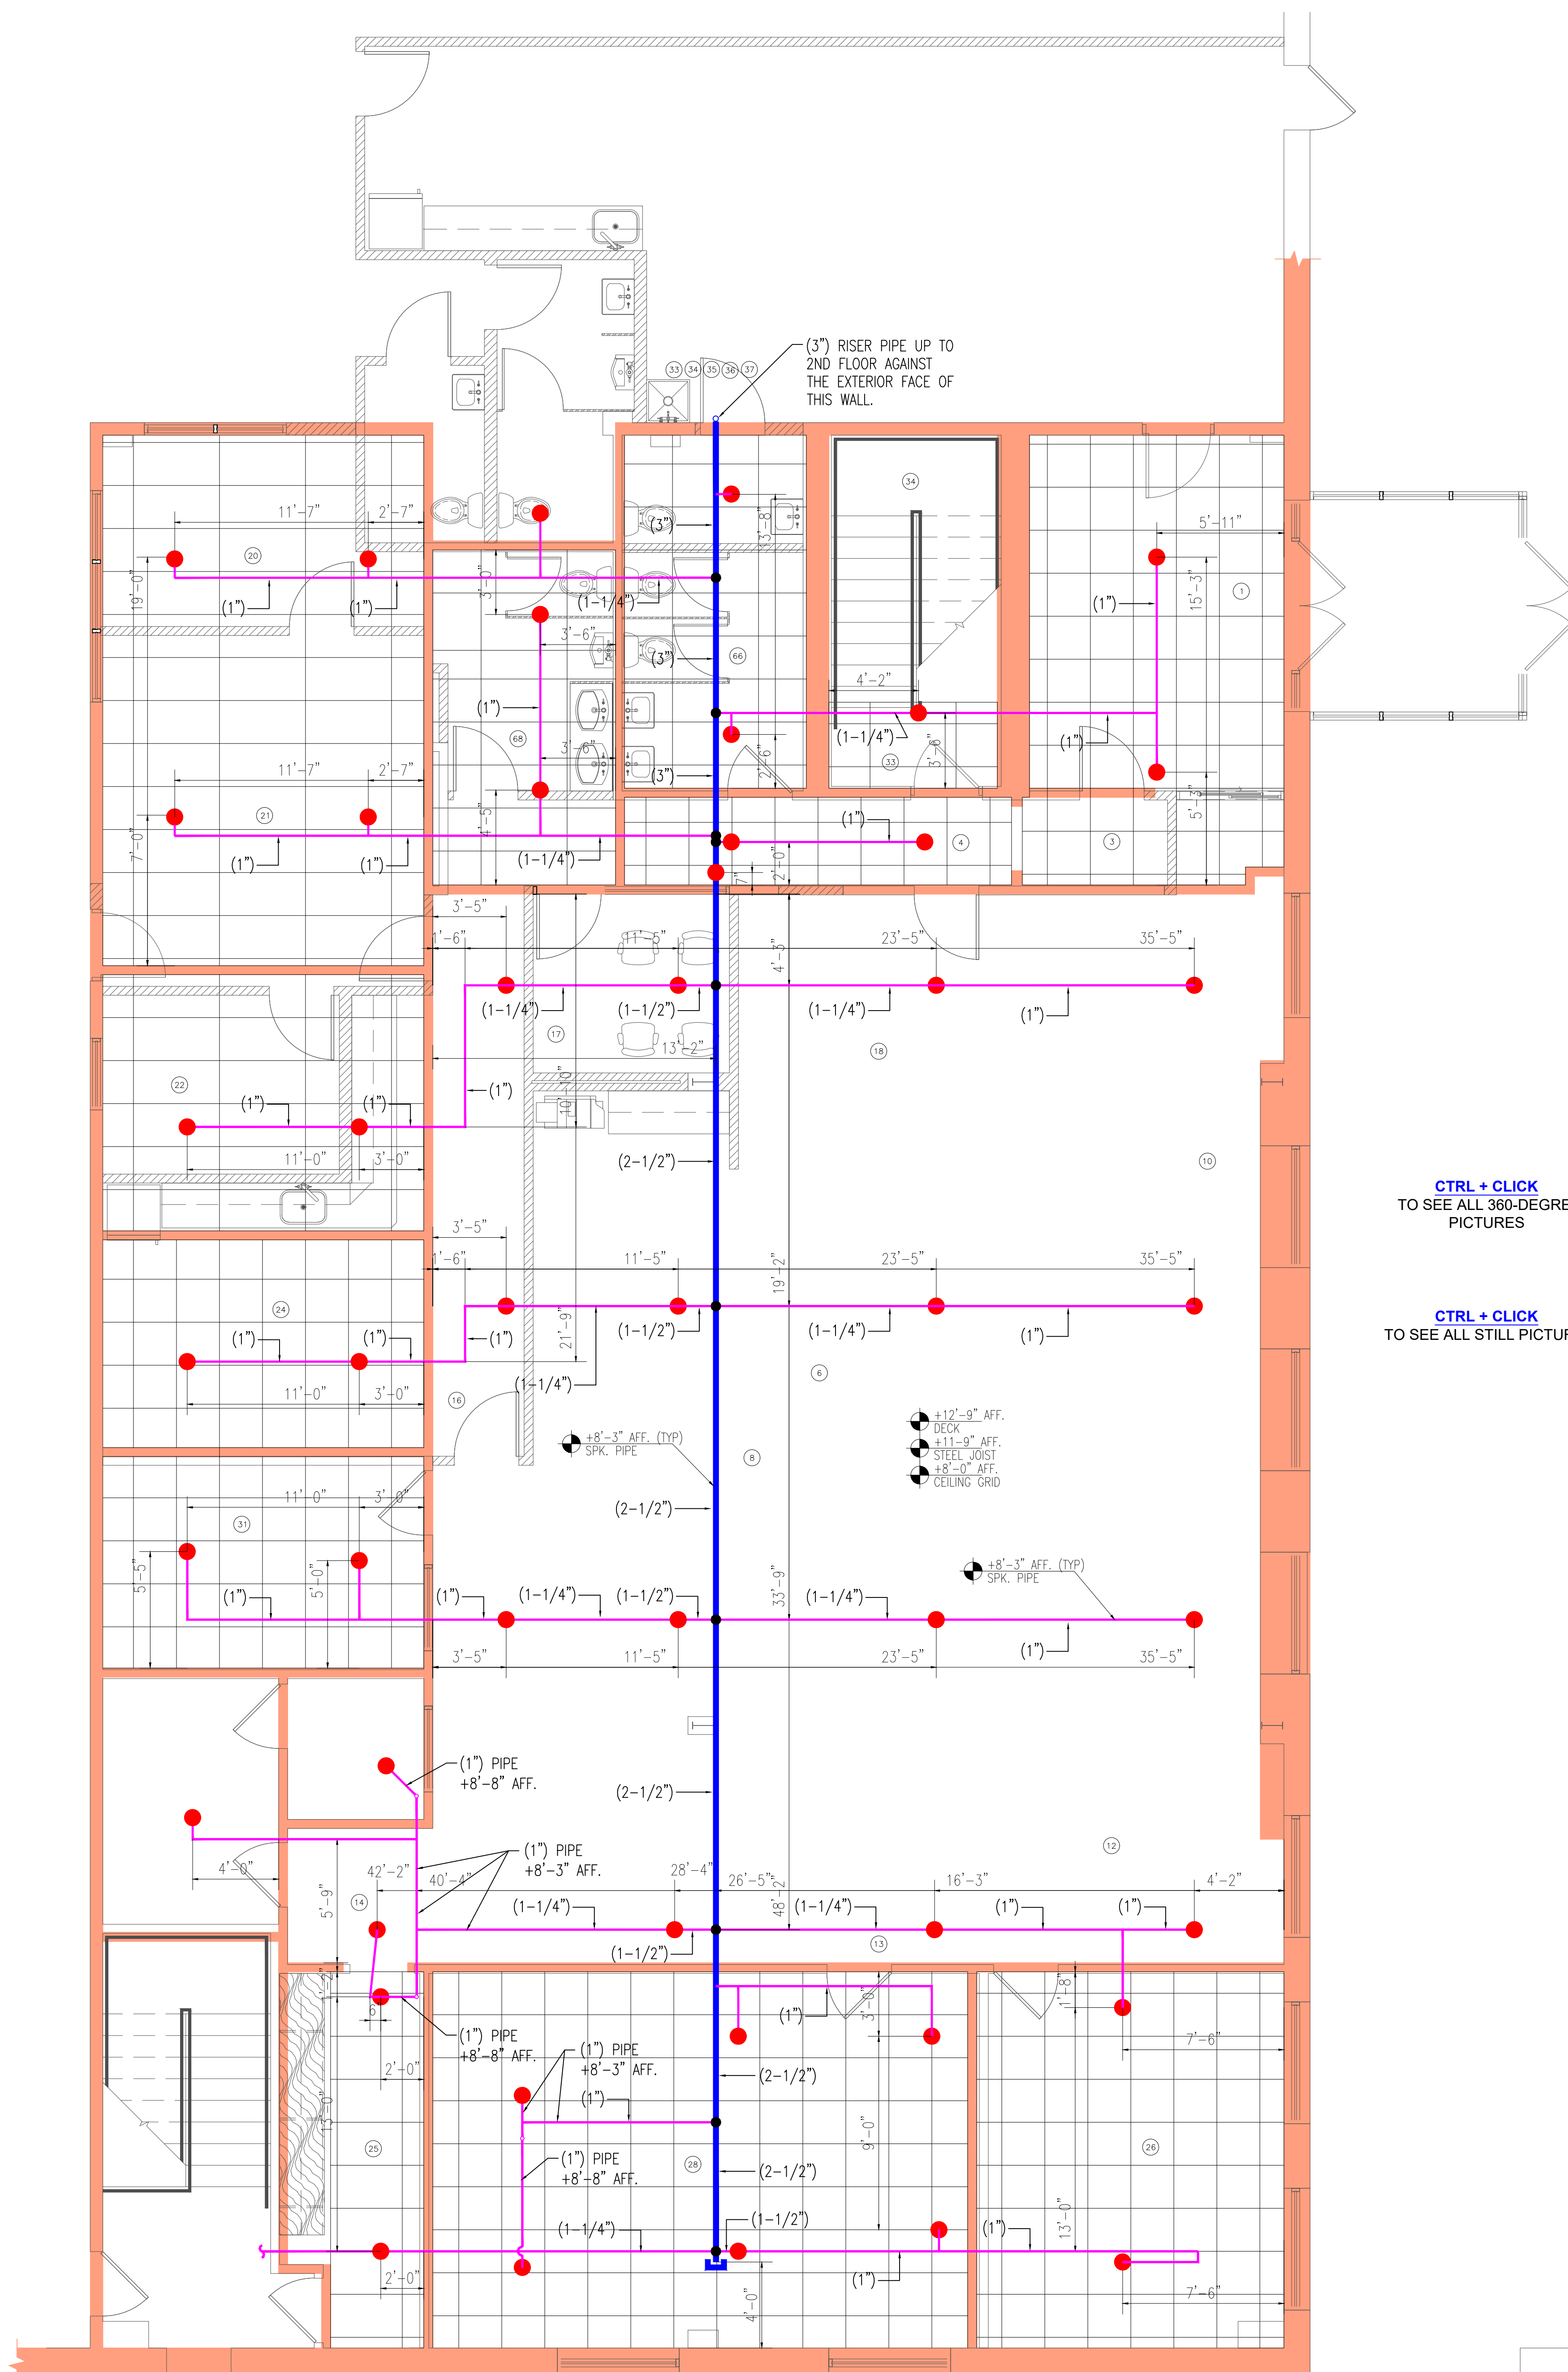

1ST FLOOR PLAN

CTRL + CLICK
 TO SEE ALL 360-DEGREE
 PICTURES

CTRL + CLICK
 TO SEE ALL STILL PICTURES

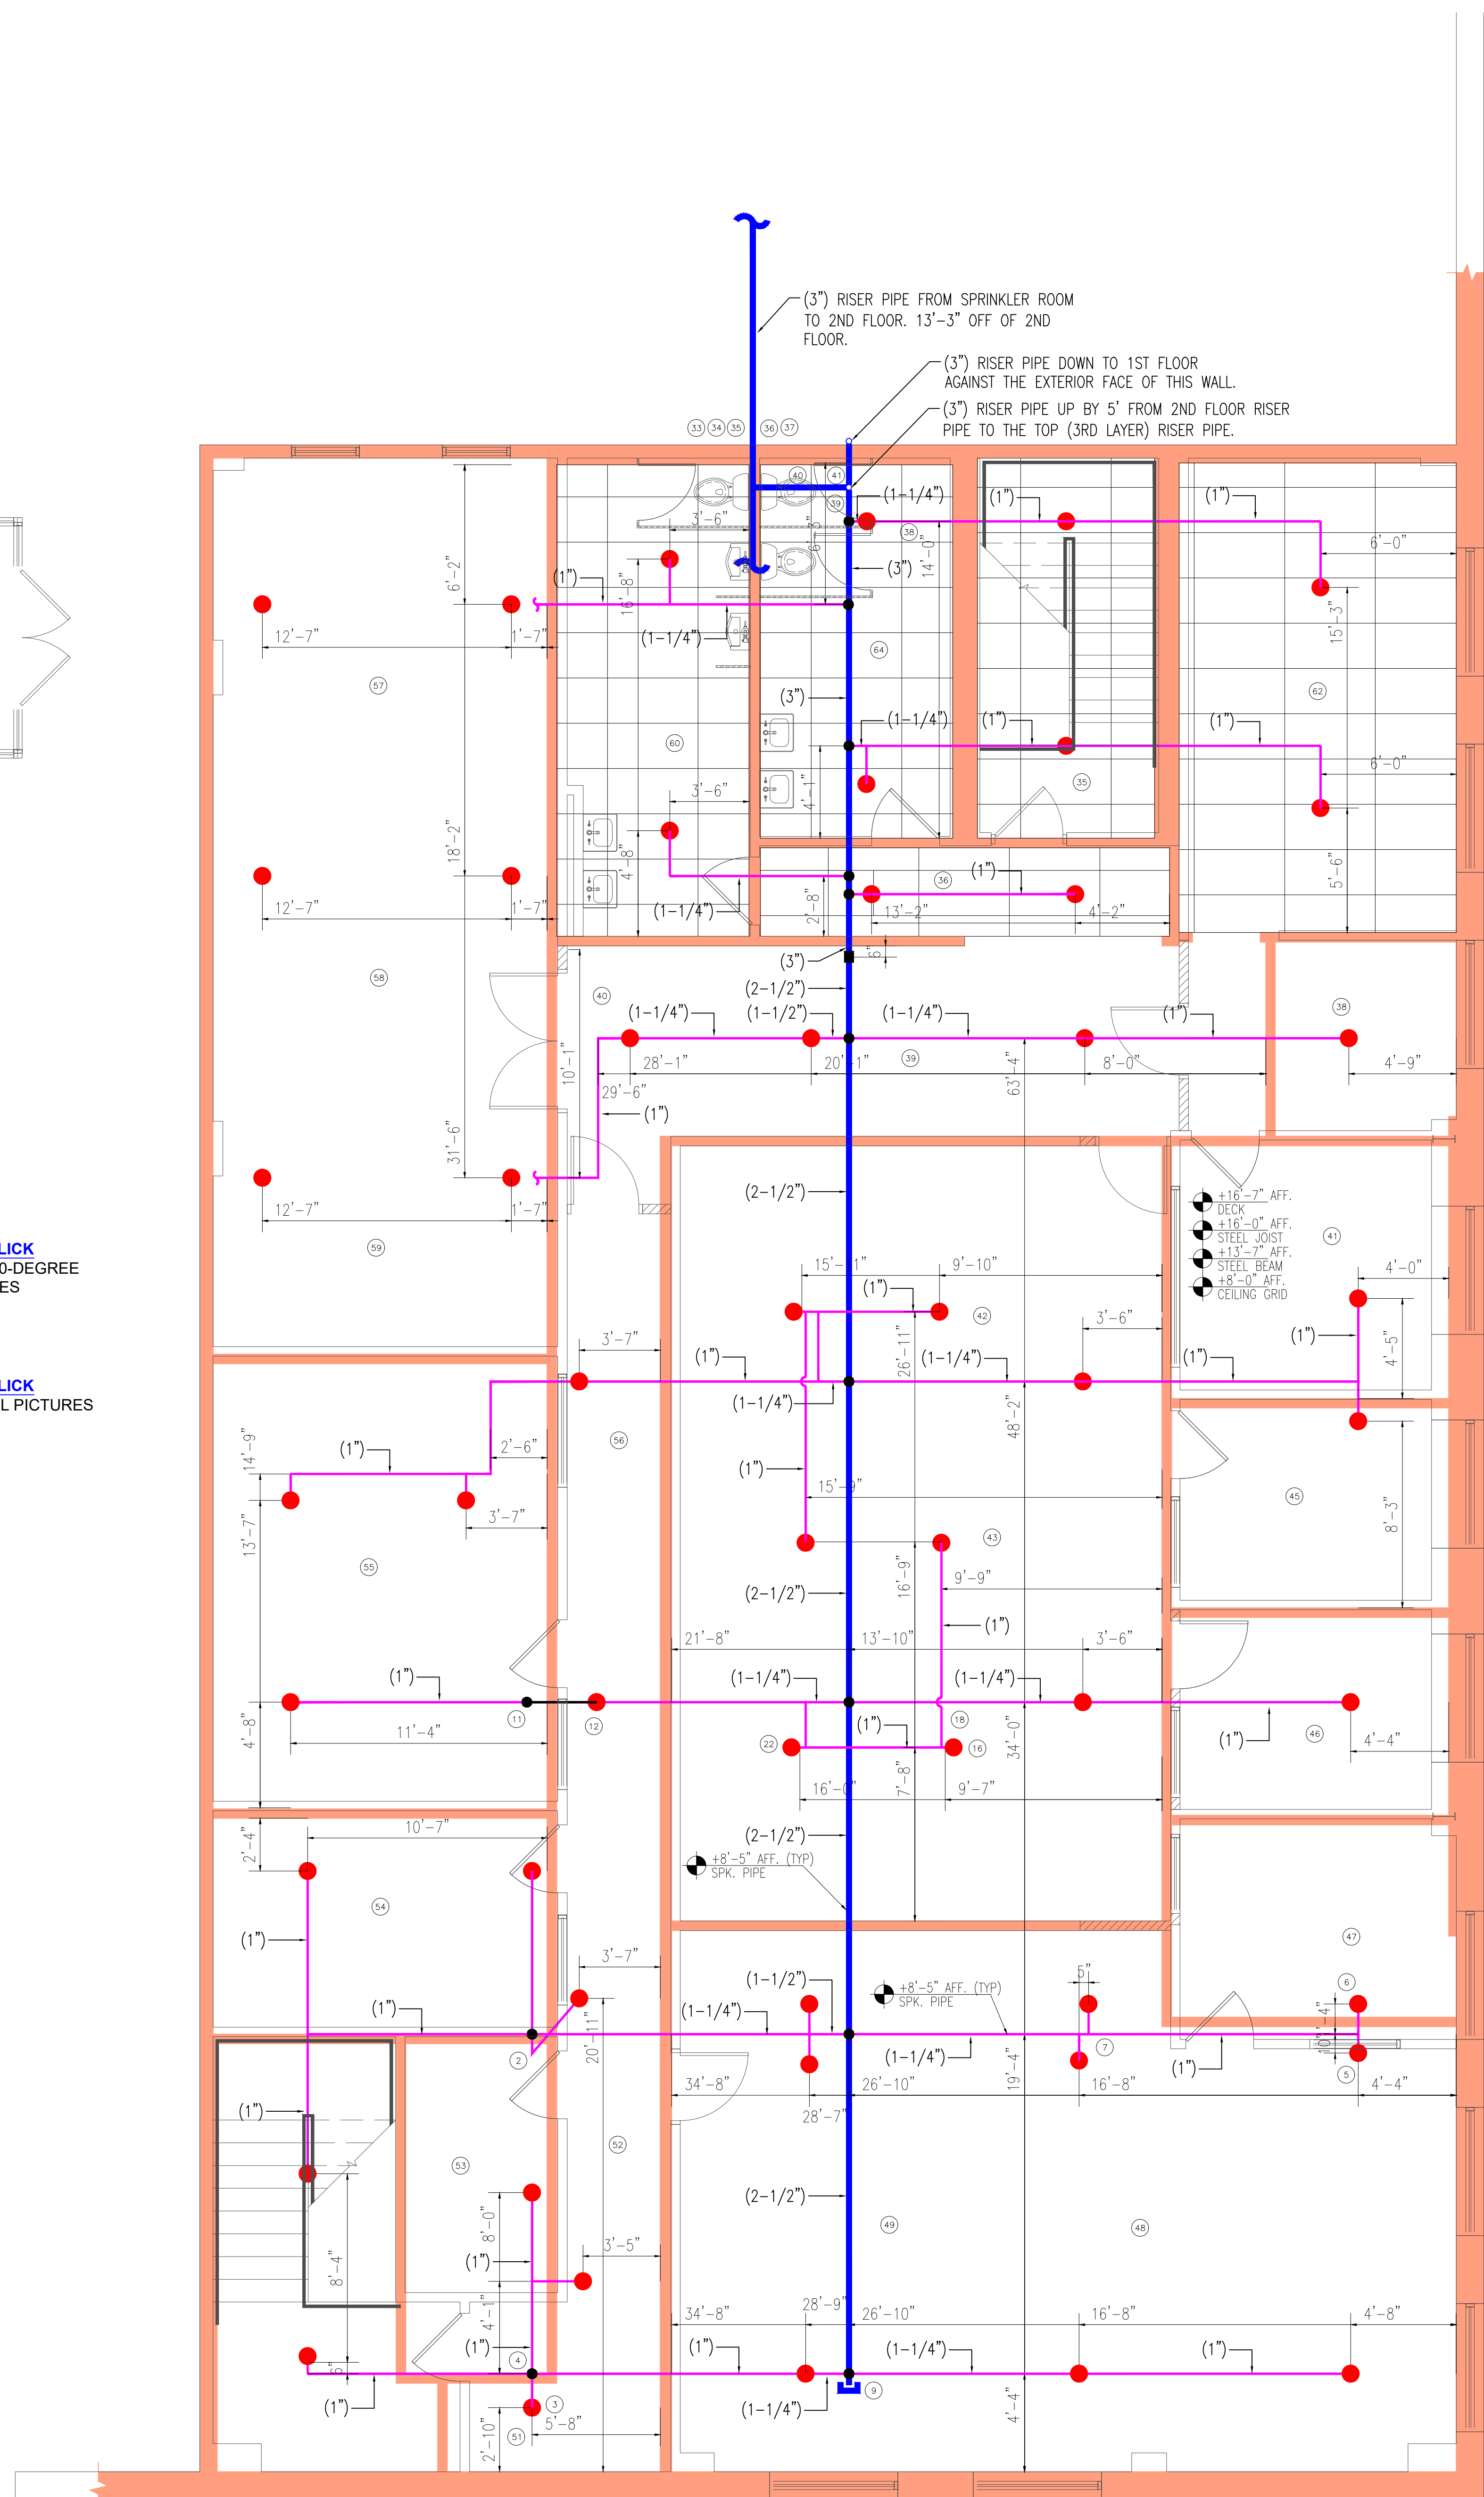

2ND FLOOR PLAN




Tel: 917-400-3011
 archasbuilt@gmail.com
 www.archasbuilt.com

DATE:	06/06/18
SURVEYED BY:	IBRAHIM ISMATI
PROJECT NO.:	18.0606
SCALE:	N.T.S.
SHEET TITLE:	

EXISTING FIRE SPRINKLER
 SYSTEM PLANS

SHEET NO.:

SP-01

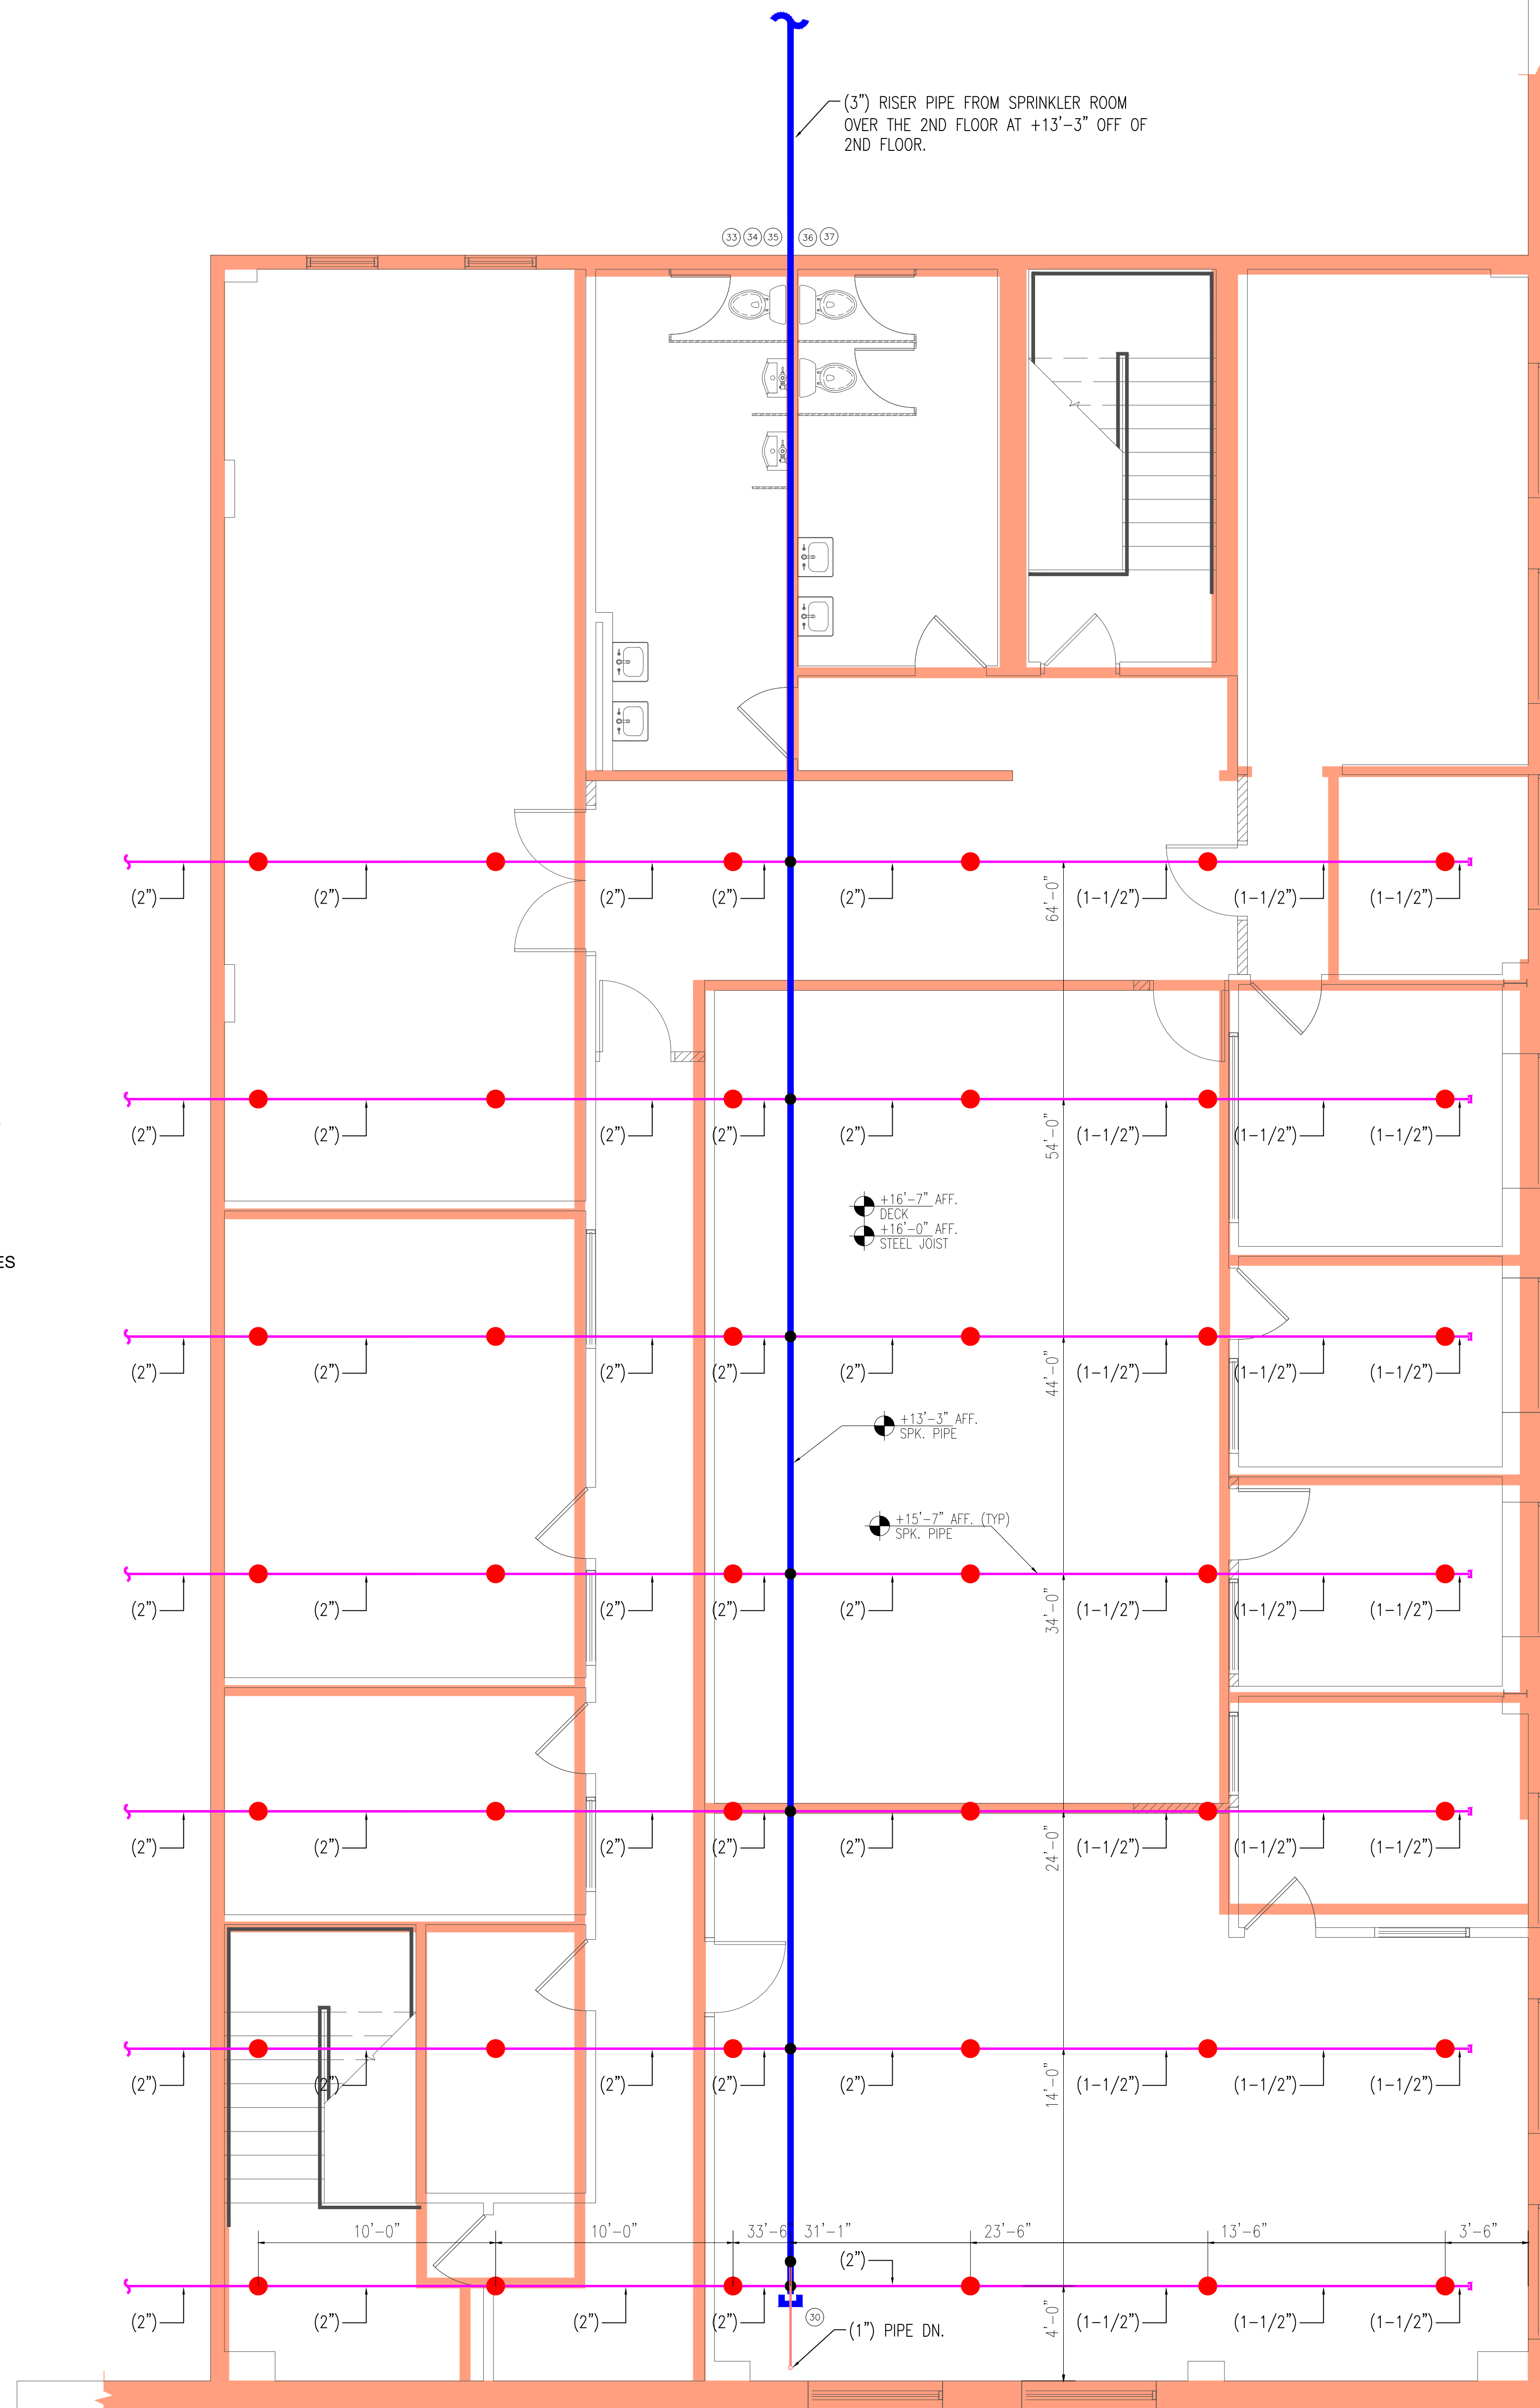

CTRL + CLICK
 TO SEE ALL 360-DEGREE
 PICTURES

CTRL + CLICK
 TO SEE ALL STILL PICTURES

2ND FLOOR PLAN