


EXISTING CONDITIONS SURVEY

Building Survey Company:

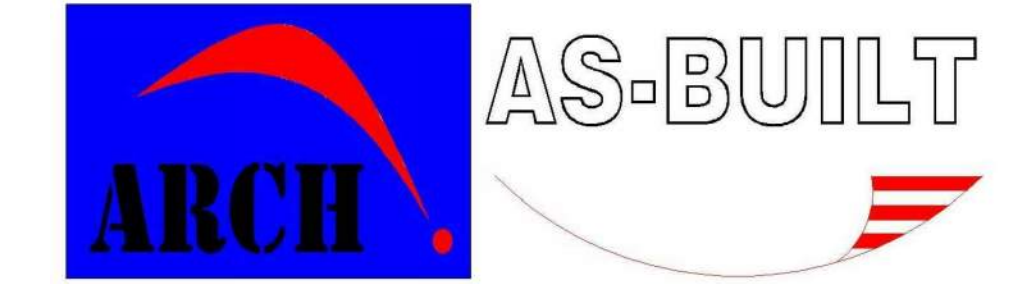


Survey & CAD Designing

Tel: 917.400.3011

Email: archasbuilt@gmail.com

www.archasbuilt.com

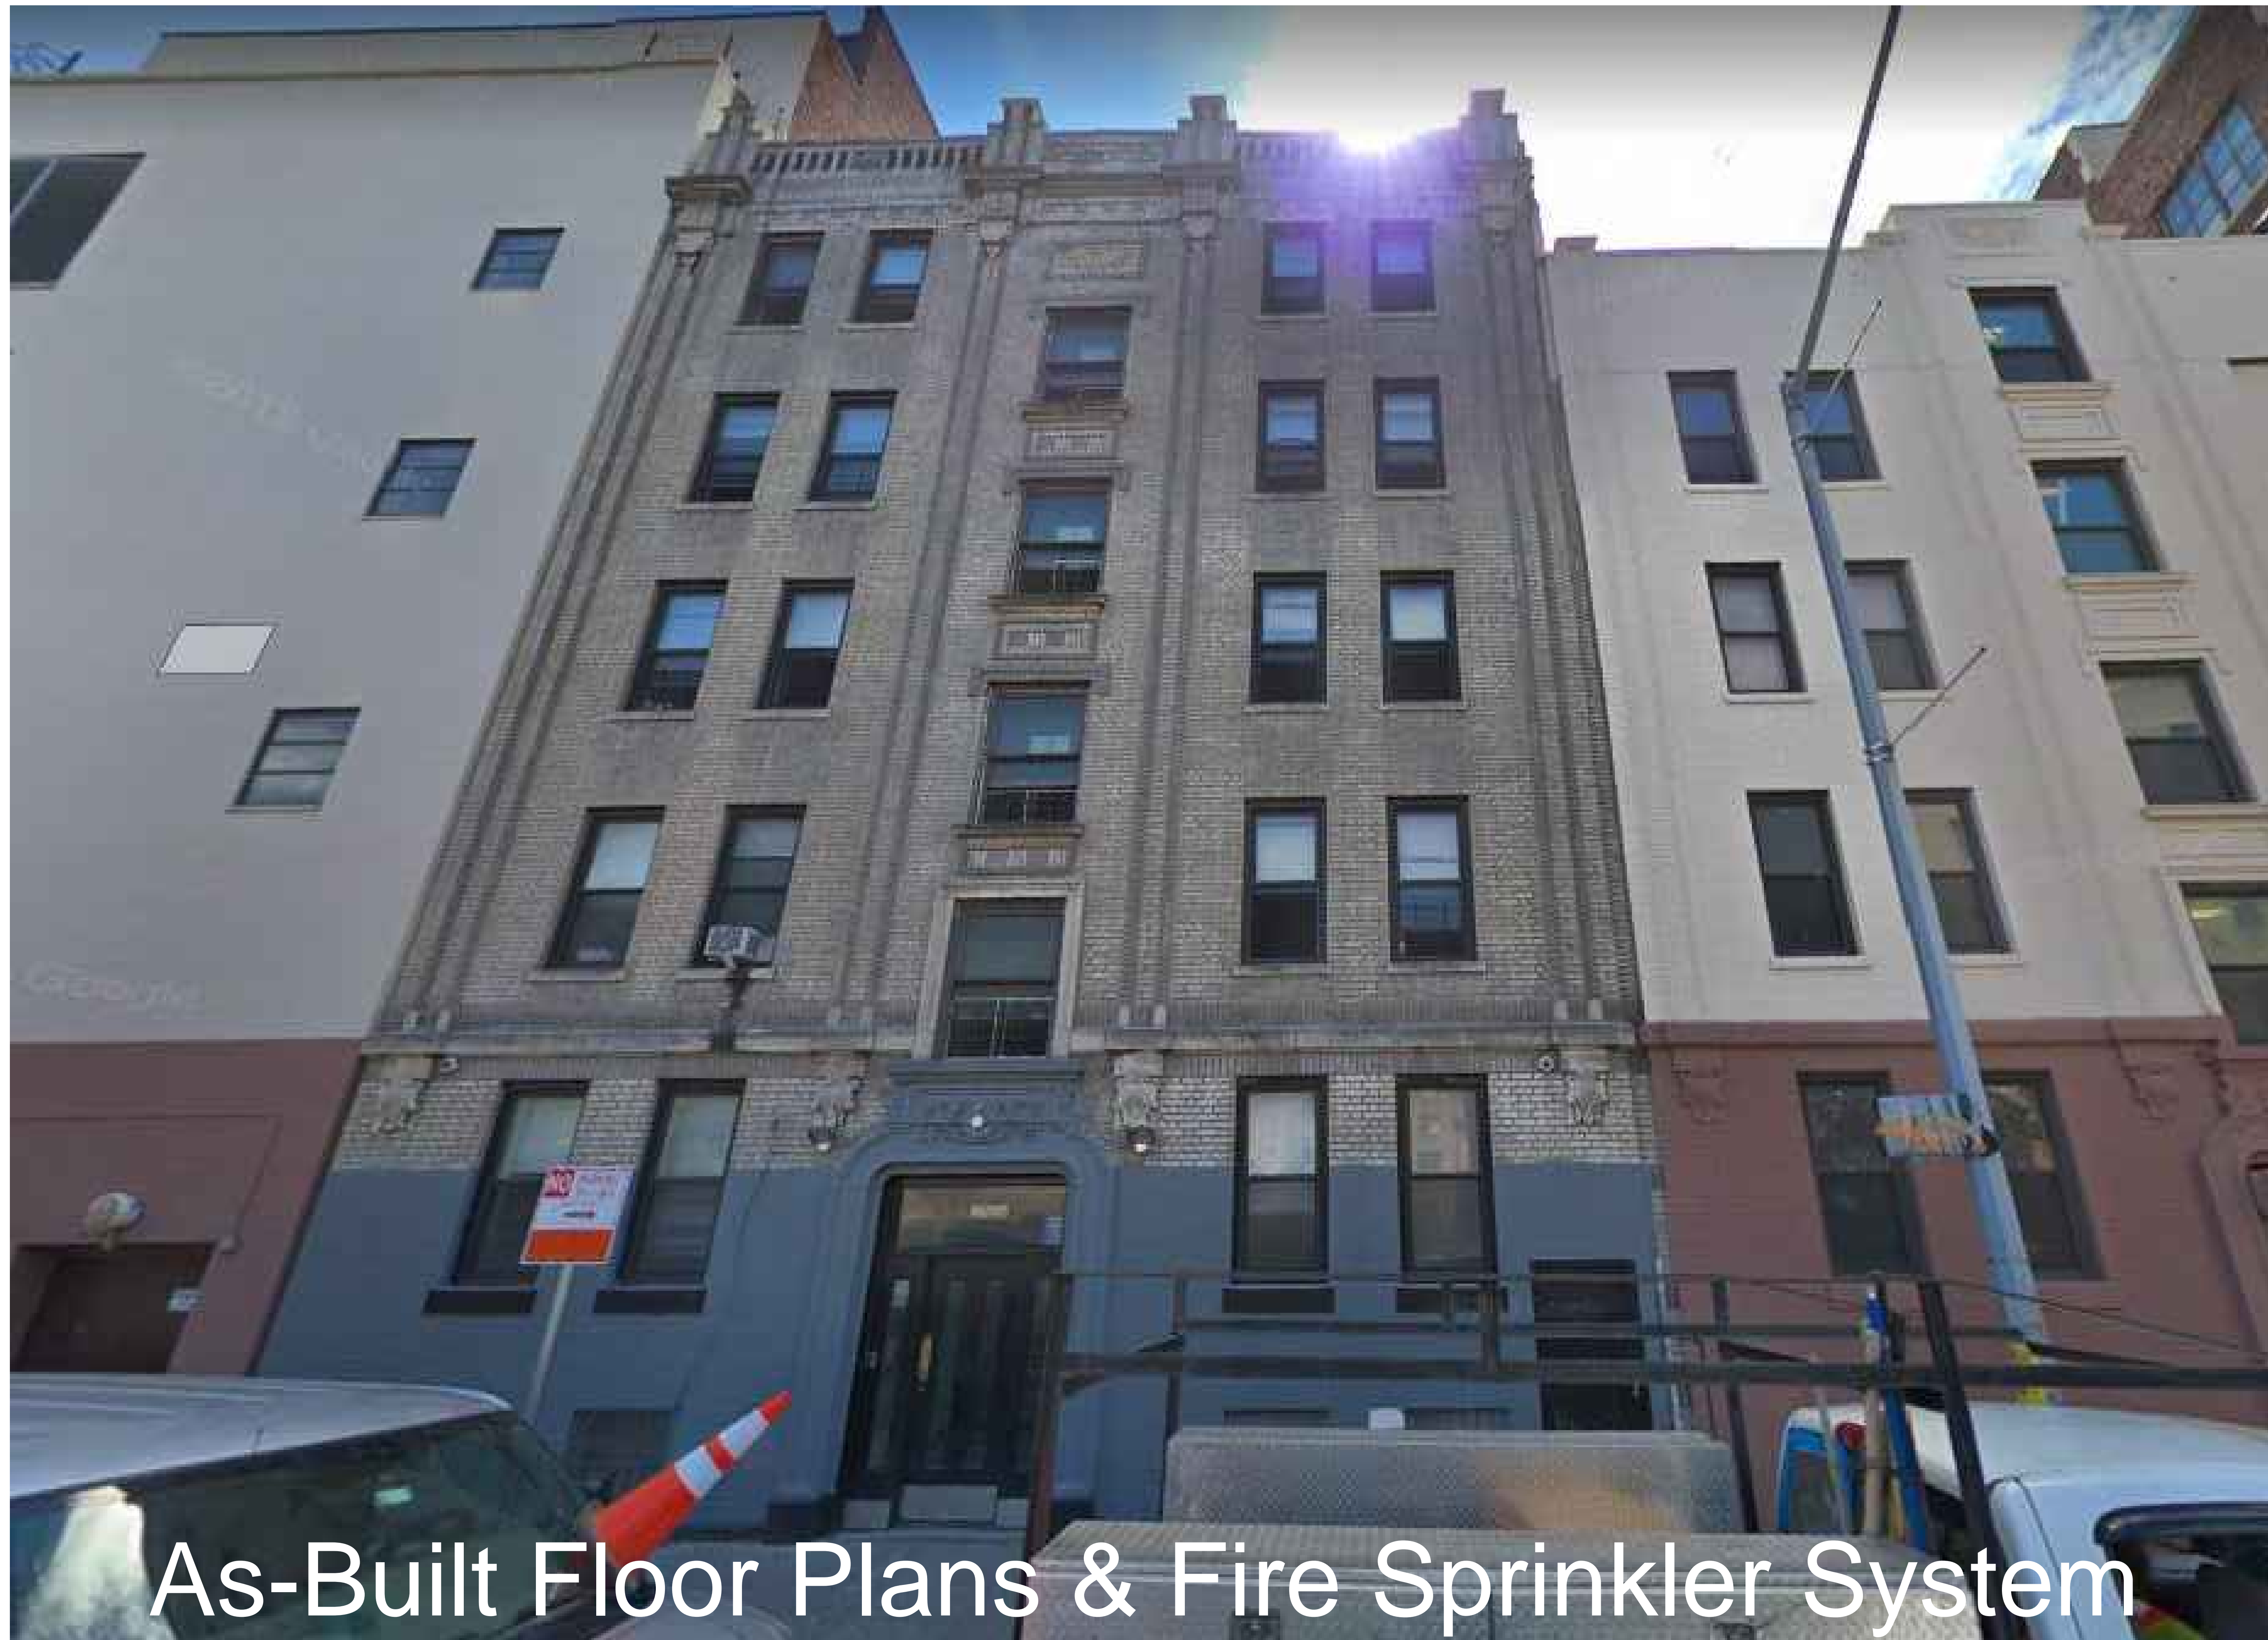

As-Built Floor Plans & Fire Sprinkler System



2524 Creston Ave, Bronx NY 10468

Client:

**JW FIRE SPRINKLER
DESIGN.**

5 Mezabish Pl, #201, Monroe NY 10950
Tel: 845.234.4599

www.jwfire.com

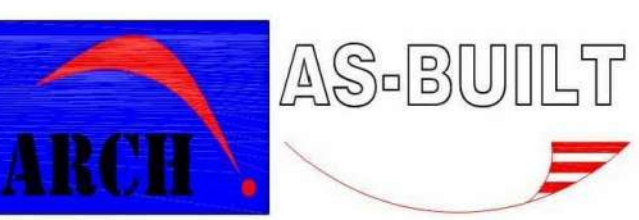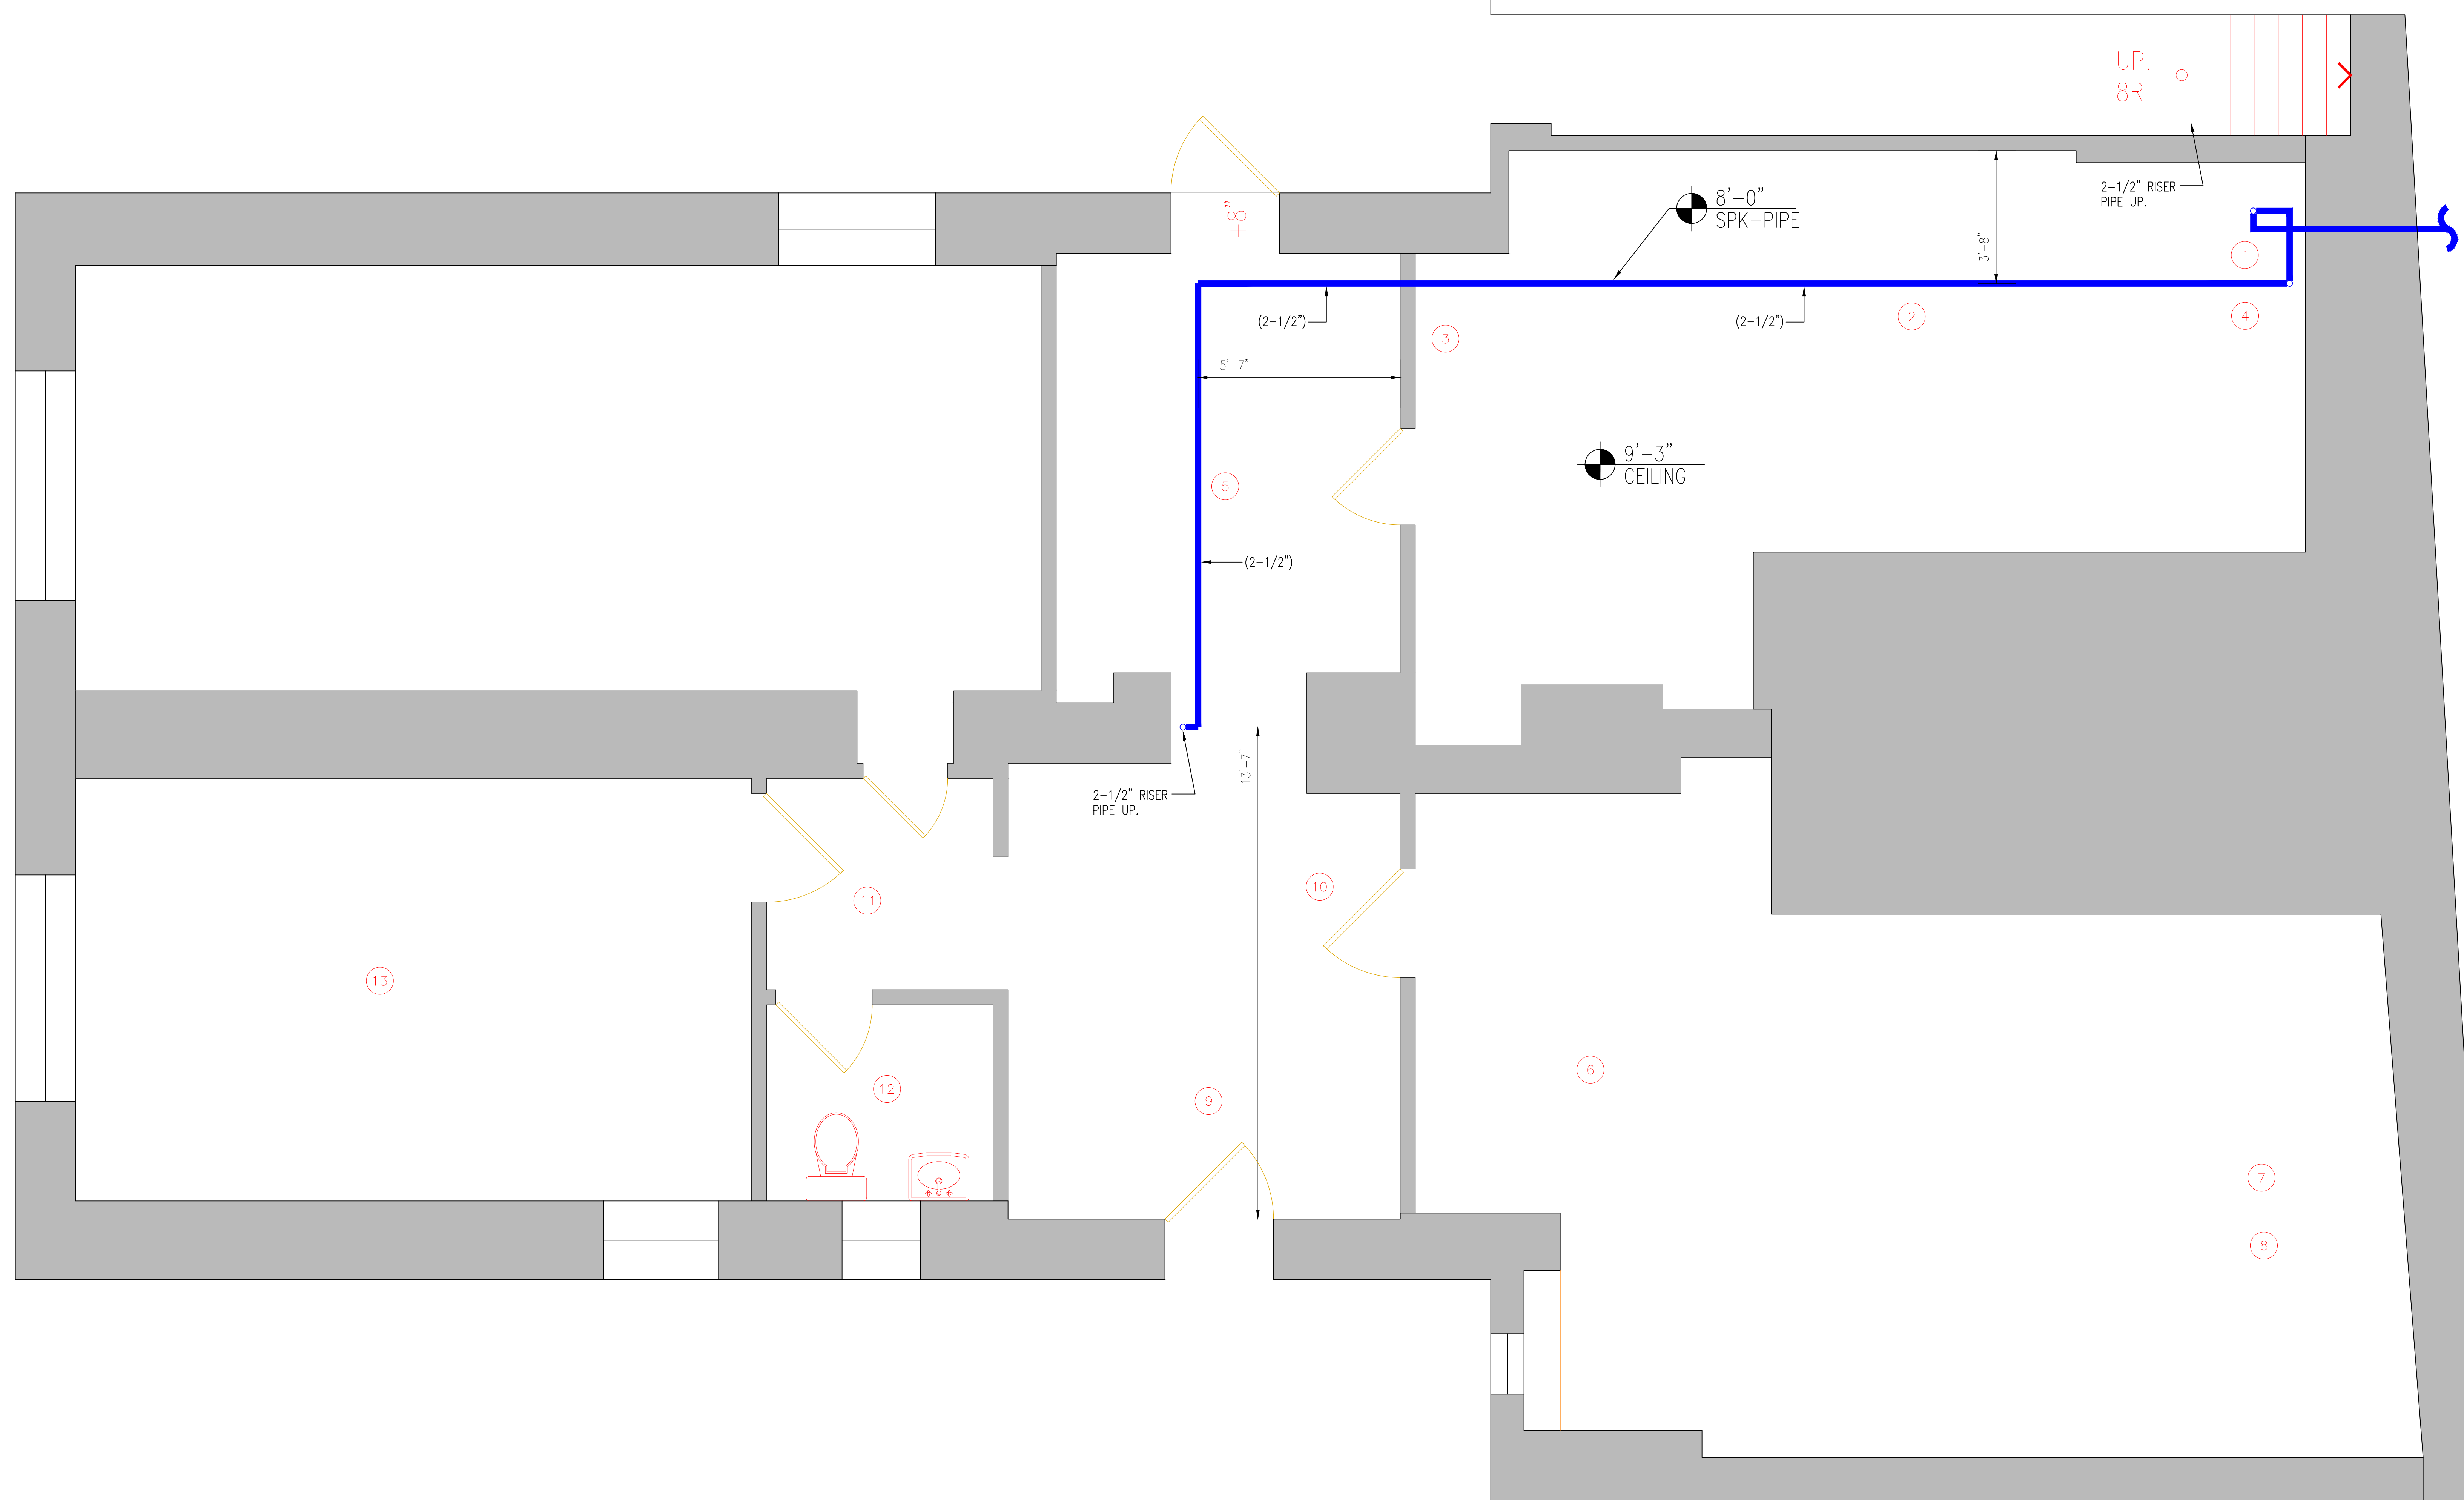



Survey & CAD Designing

Tel: 917-400-3011
archasbuilt@gmail.com
www.archasbuilt.com

DATE:	11/30/17
SURVEYED BY:	IBRAHIM SMATI
PROJECT NO:	17.1130
SCALE:	N.T.S
SHEET TITLE:	

**EXISTING SPRINKLER
SYSTEM SEURVEY NOTE**

SHEET NO:

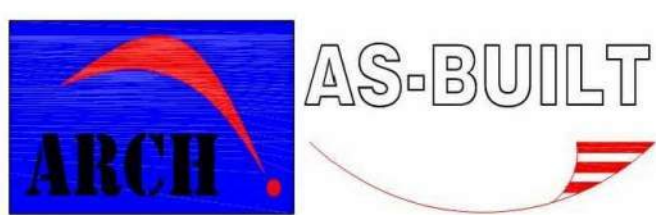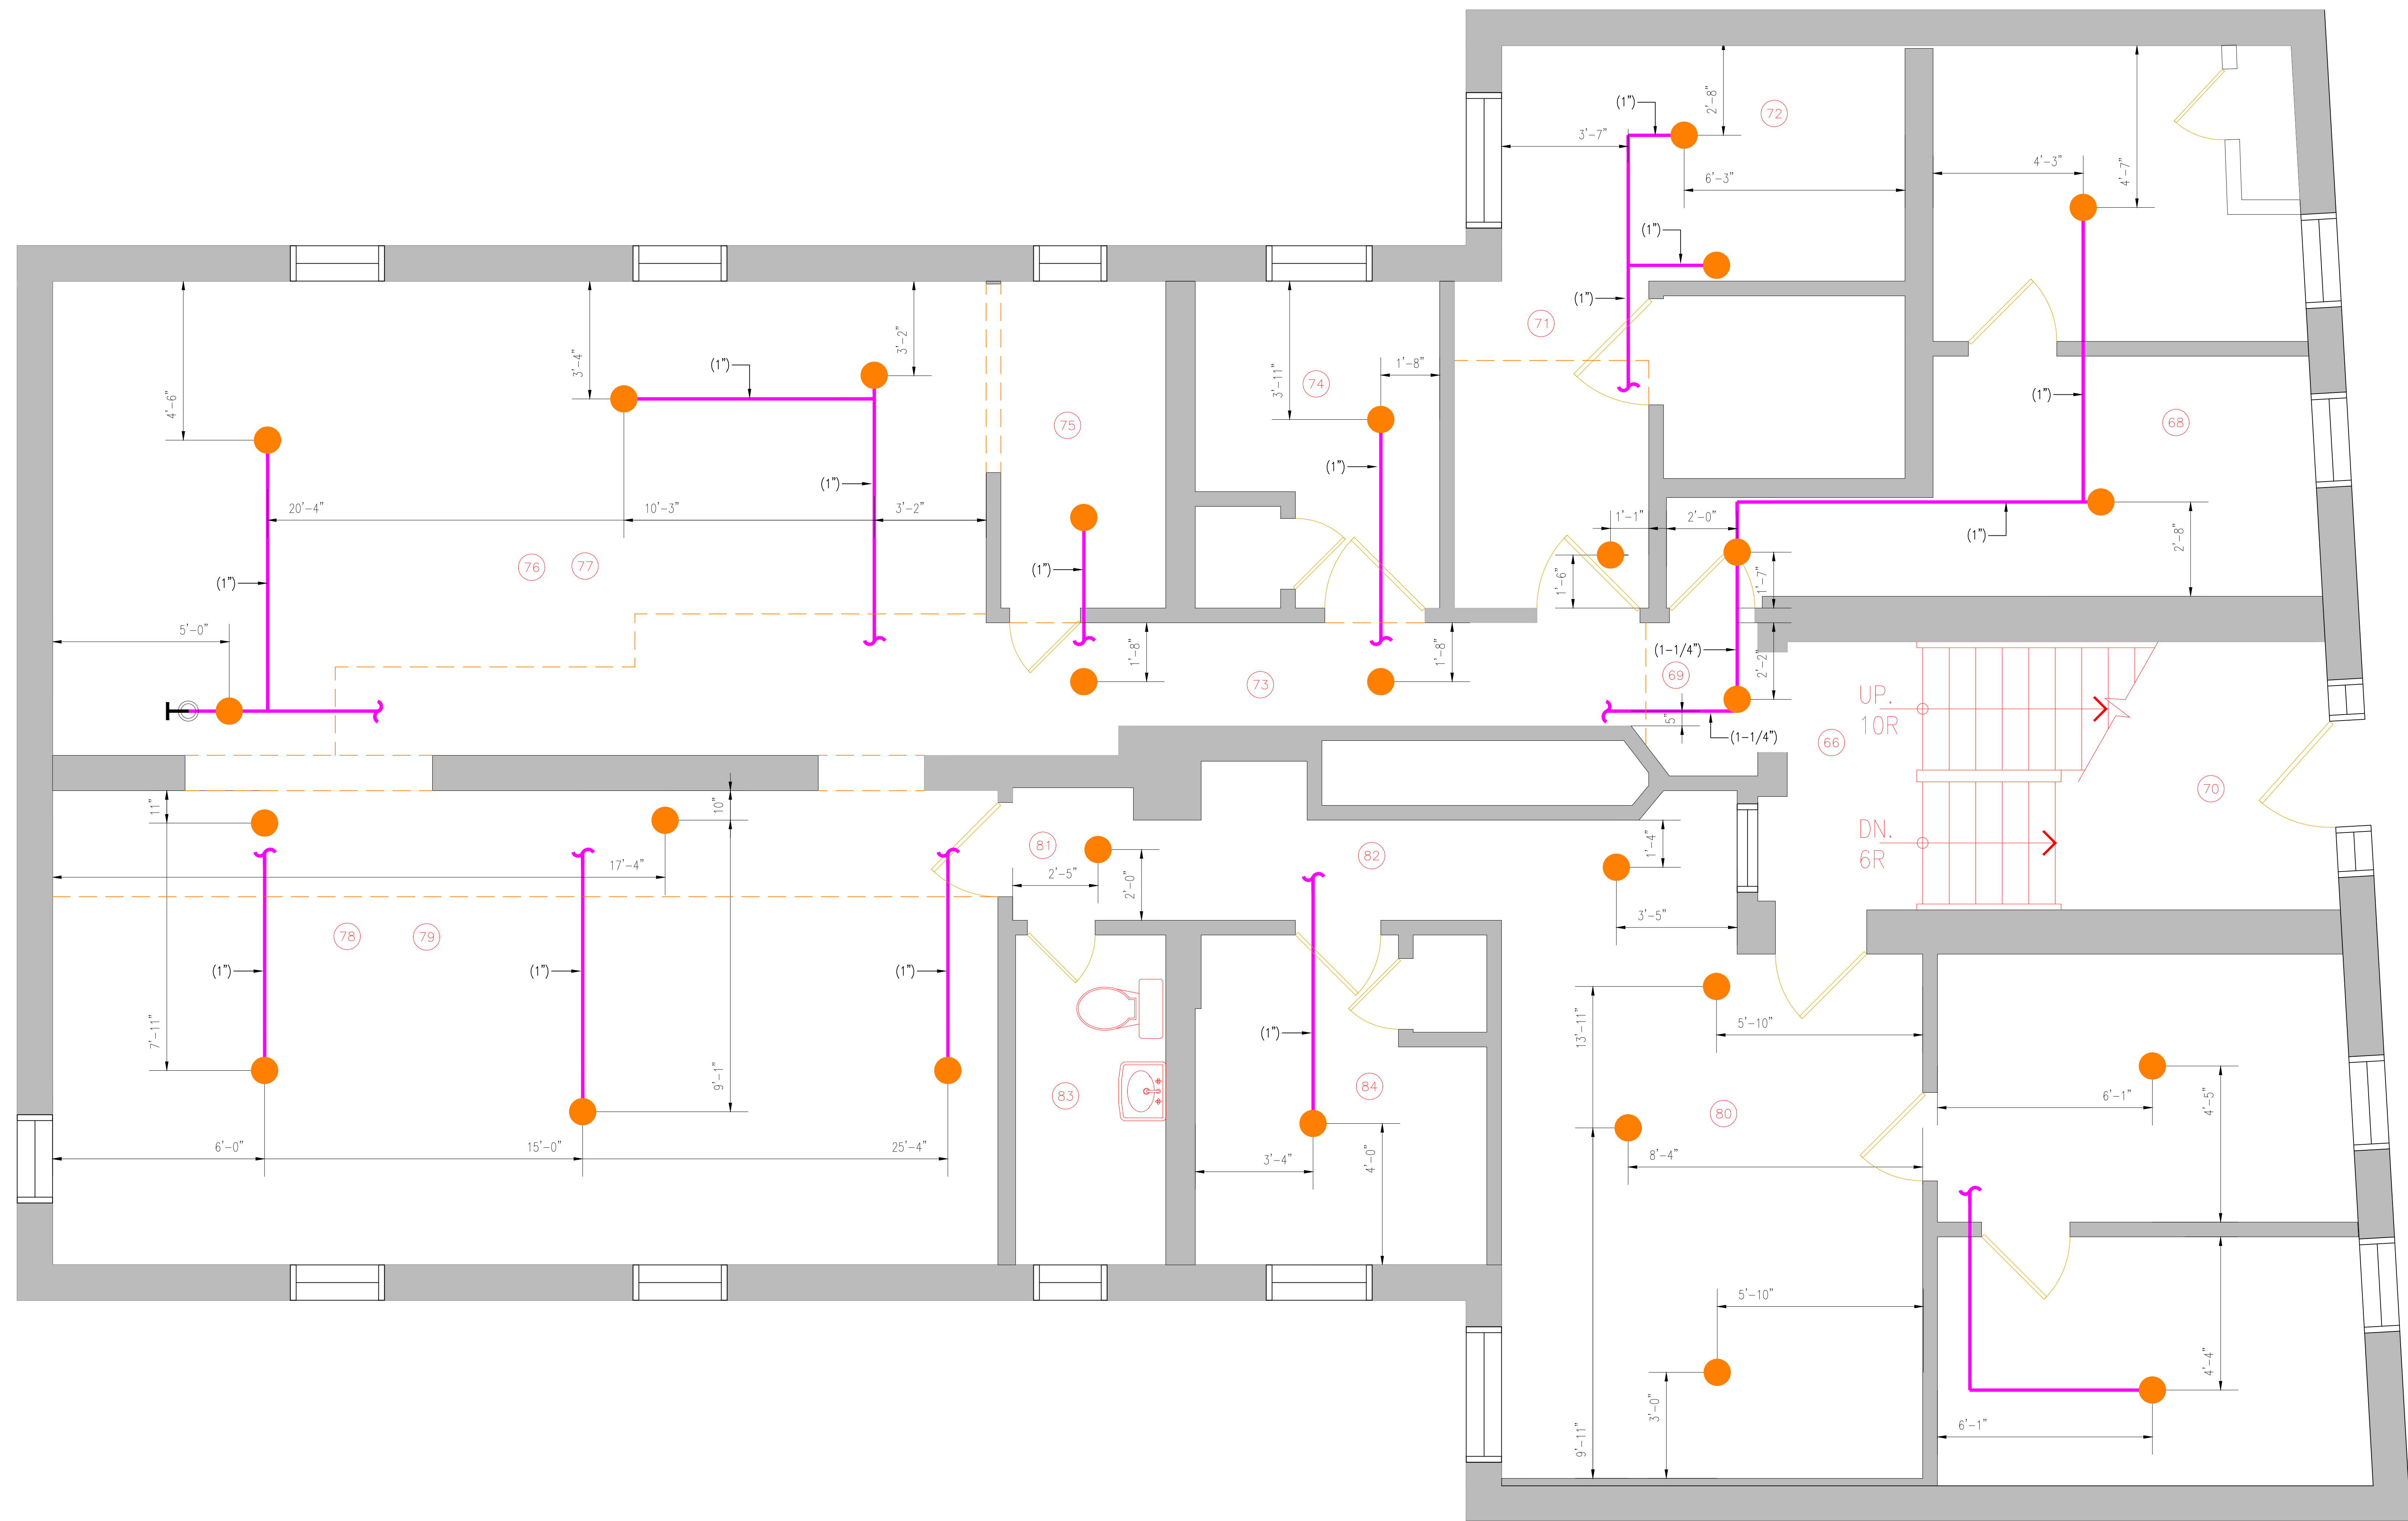


Survey & CAD Designing

Tel: 917-400-3011
archasbuilt@gmail.com
www.archasbuilt.com

DATE:	11/30/17
SURVEYED BY:	IBRAHIM ISMATI
PROJECT NO:	17.1130
SCALE:	N.T.S
SHEET TITLE:	

EXISTING SPRINKLER
SYSTEM SEURVEY NOTE

SHEET NO:

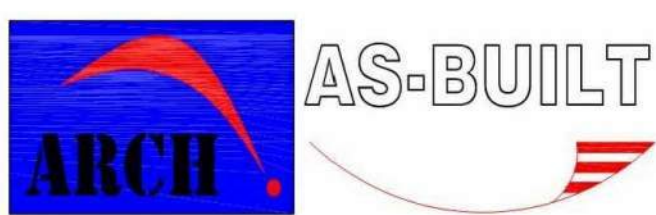



Survey & CAD Designing

Tel: 917-400-3011
archasbuilt@gmail.com
www.archasbuilt.com

DATE: 11/30/17
SURVEYED BY: IBRAHIM SMATI
PROJECT NO: 17.1130
SCALE: N.T.S.
SHEET TITLE:

EXISTING SPRINKLER
SYSTEM SEURVEY NOTE

SHEET NO:

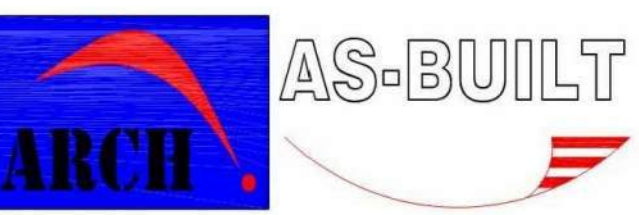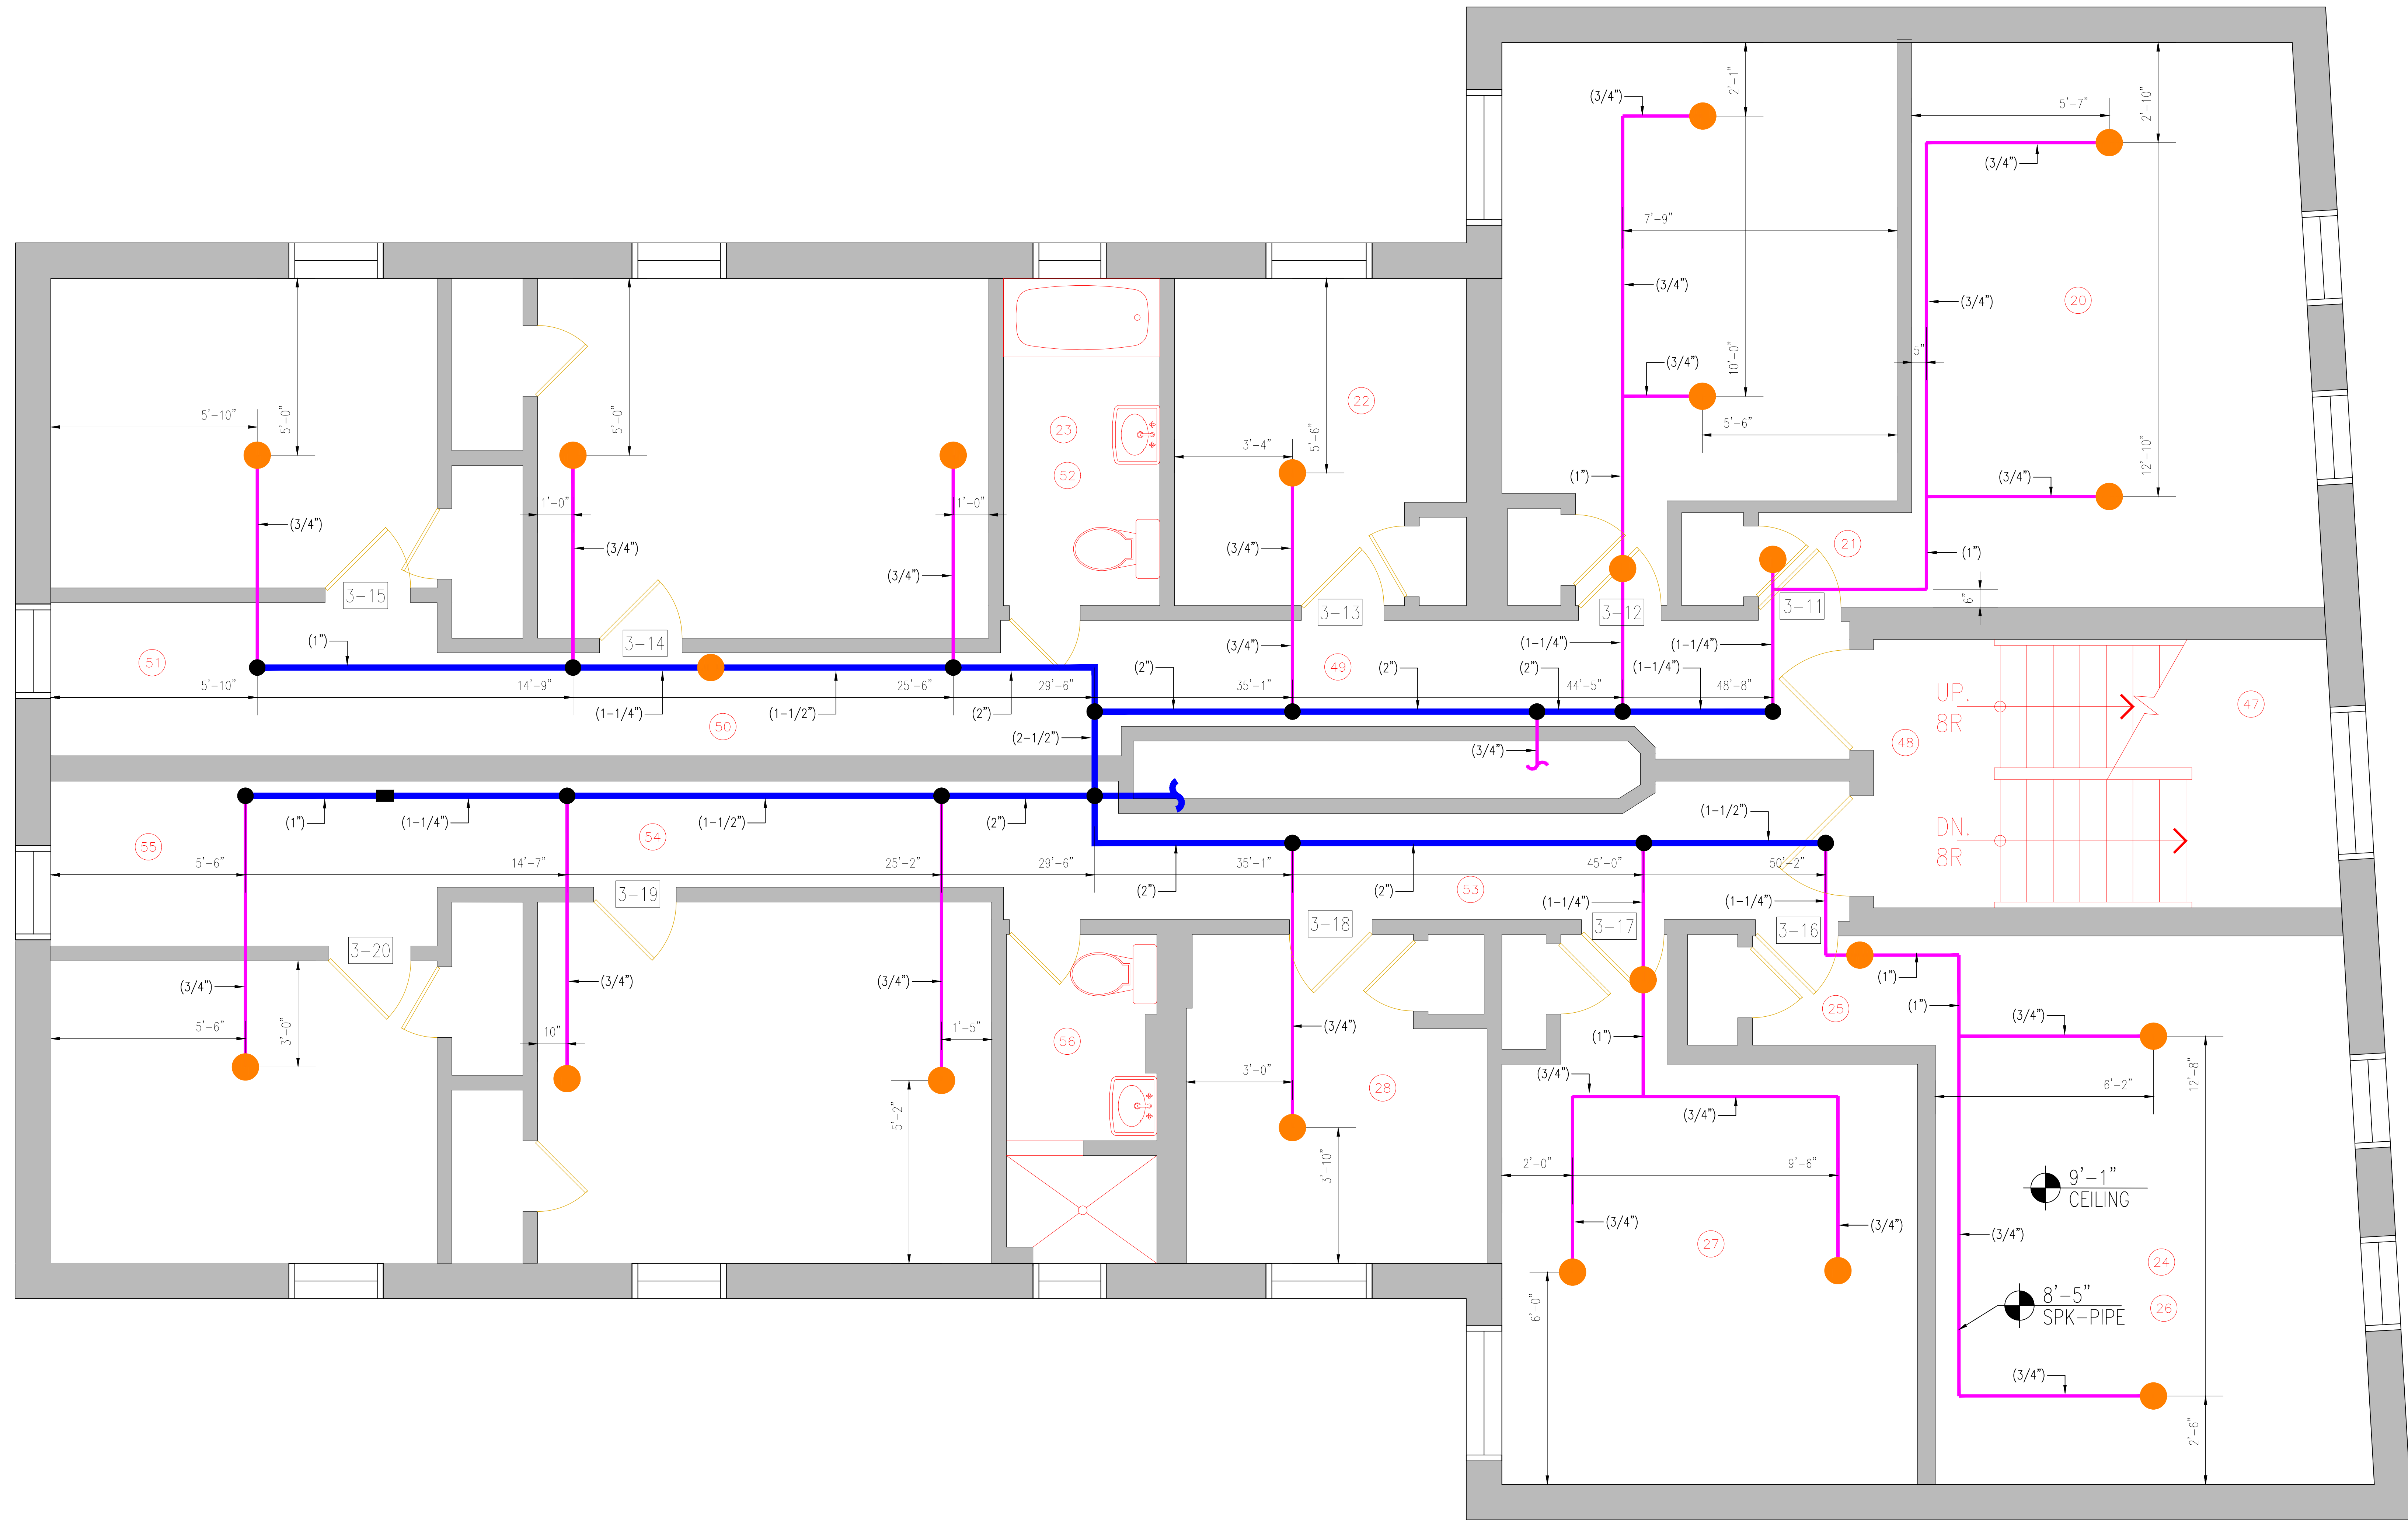



Survey & CAD Designing

Tel: 917-400-3011
archasbuilt@gmail.com
www.archasbuilt.com

DATE:	11/30/17
SURVEYED BY:	IBRAHIM SMATI
PROJECT NO:	17.1130
SCALE:	N.T.S
SHEET TITLE:	

EXISTING SPRINKLER
SYSTEM SEURVEY NOTE

SHEET NO:

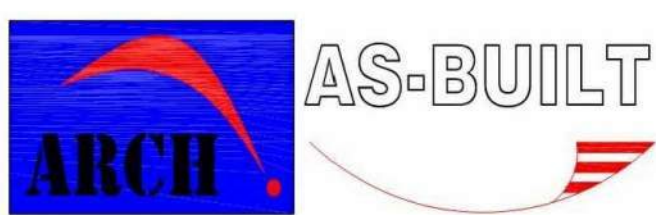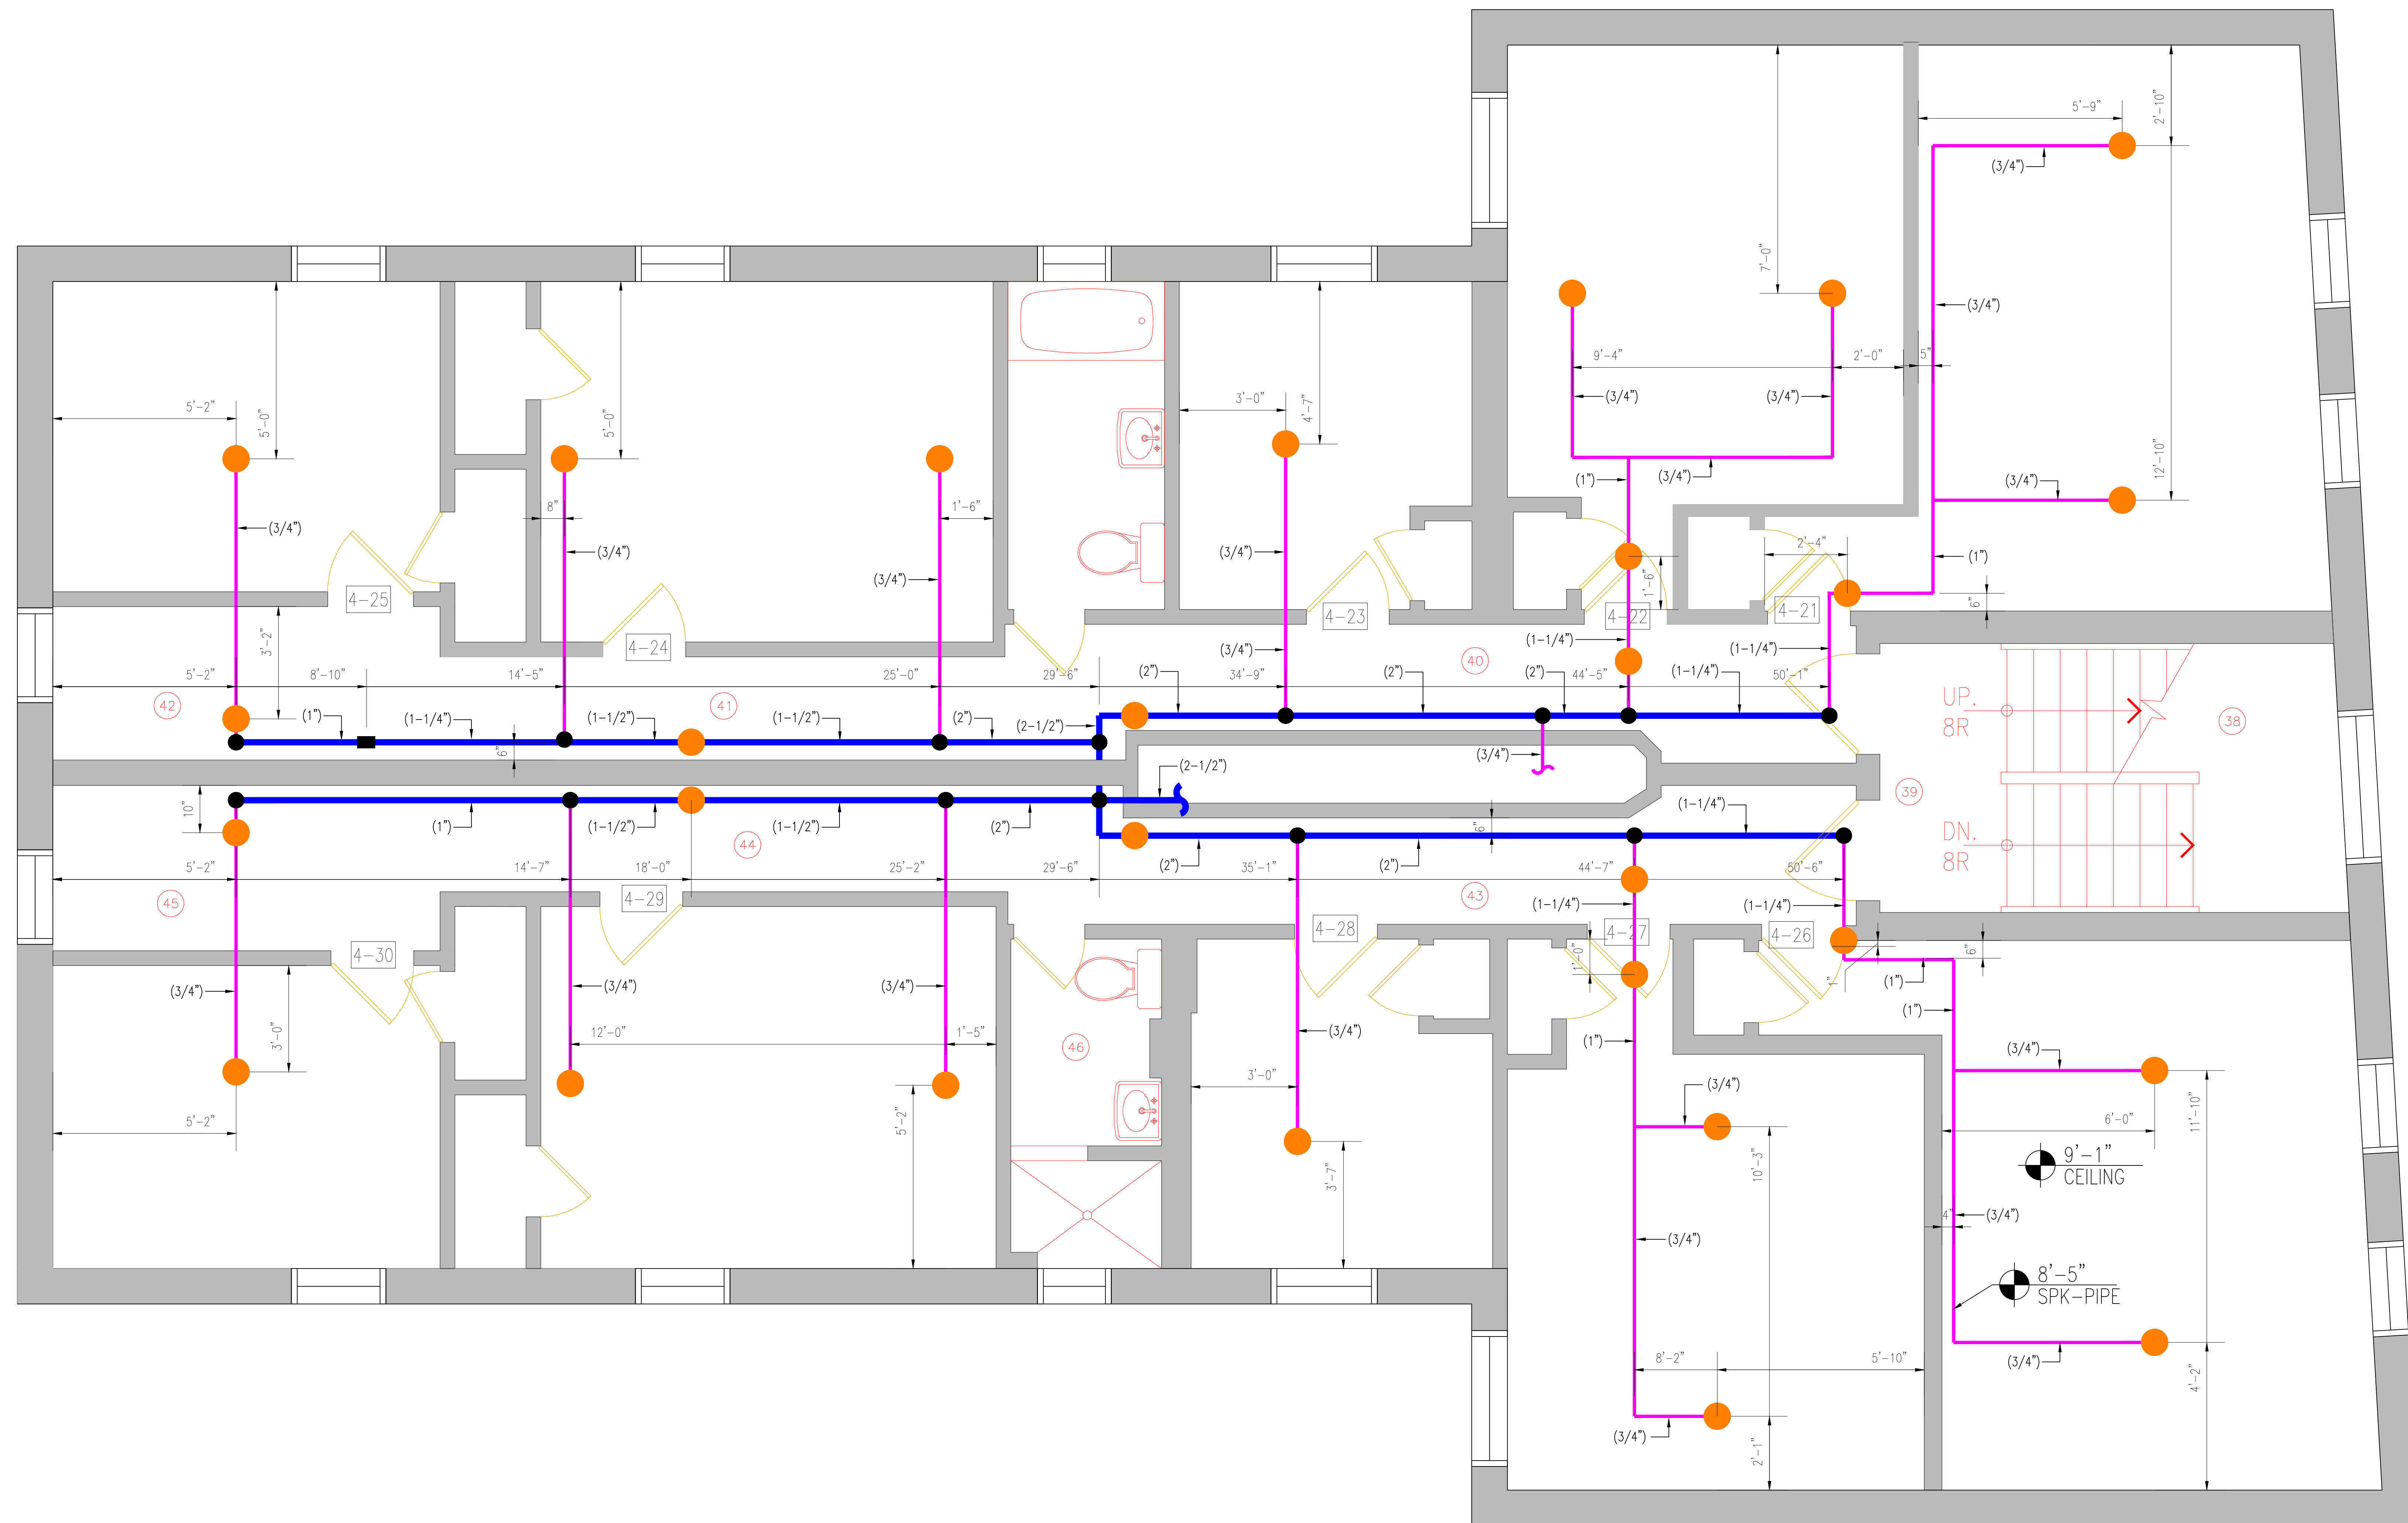



ARCH AS-BUILT
Survey & CAD Designing

Tel: 917-400-3011
archasbuilt@gmail.com
www.archasbuilt.com

DATE: 11/30/17
SURVEYED BY: IBRAHIM SMATI
PROJECT NO: 17.1130
SCALE: N.T.S.
SHEET TITLE:

EXISTING SPRINKLER
SYSTEM SEURVEY NOTE

SHEET NO:

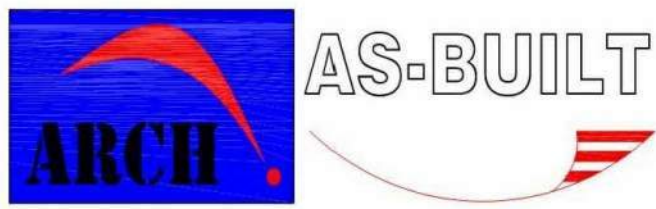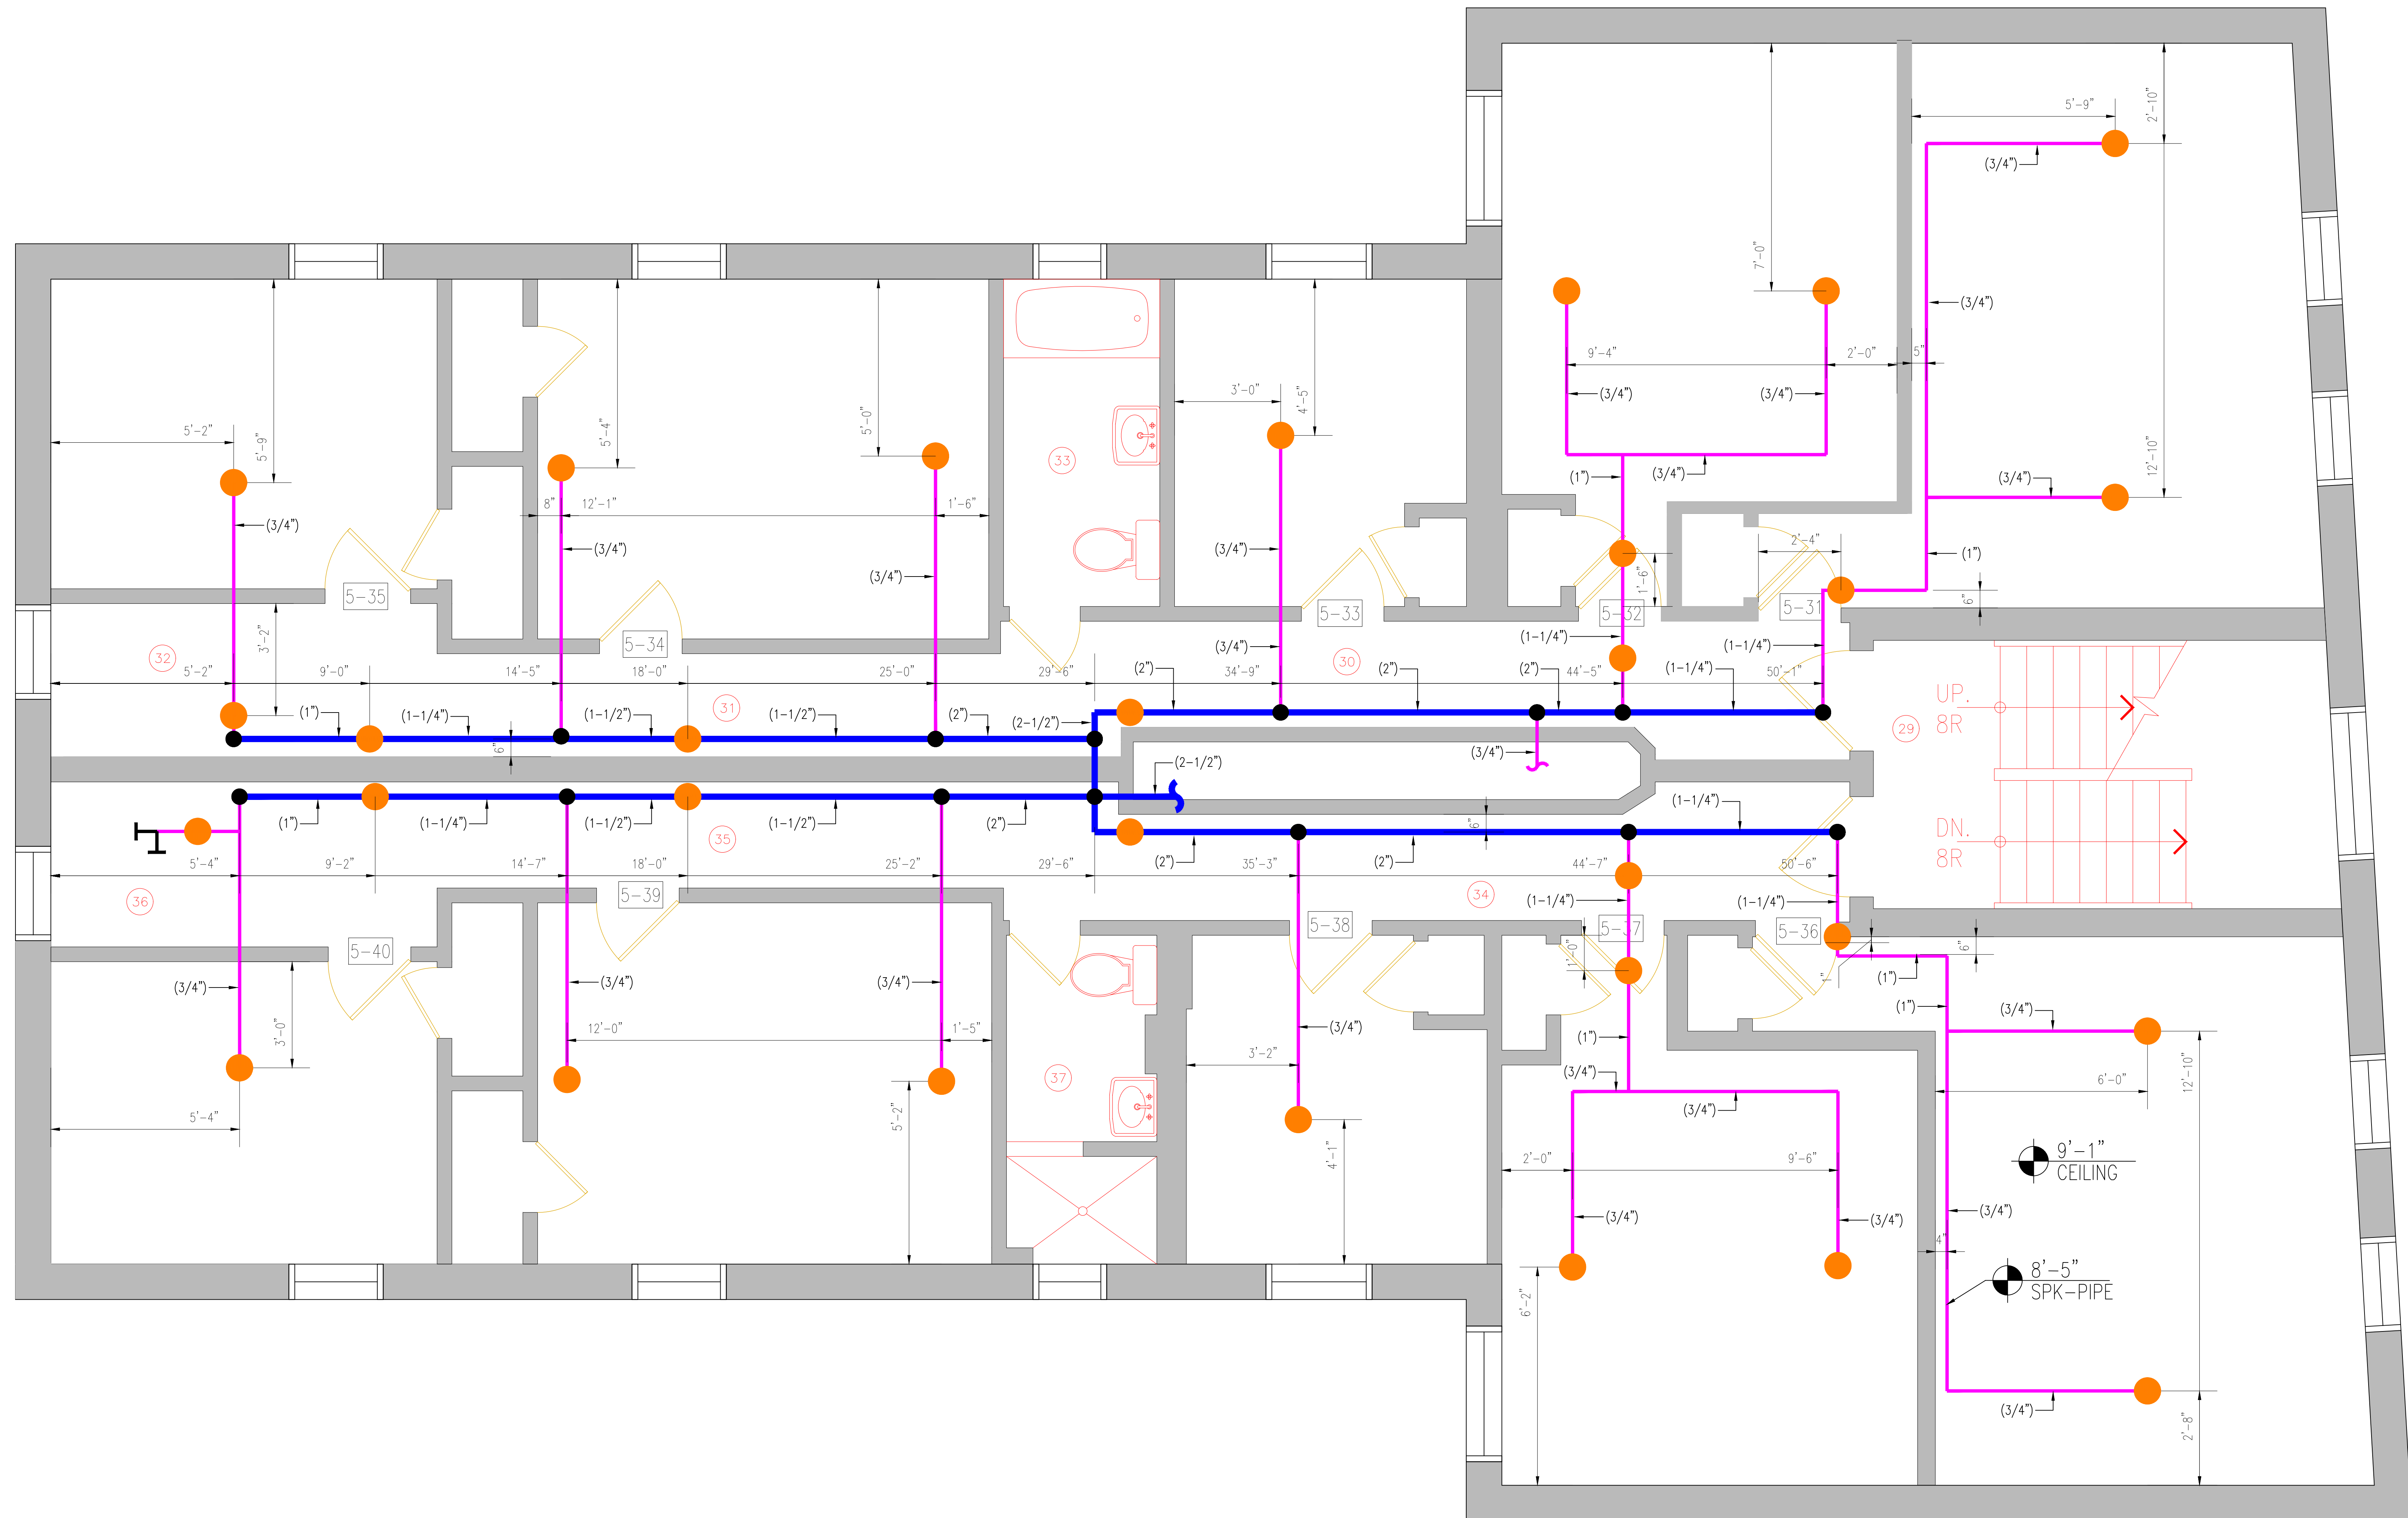

Survey & CAD Designing

Tel: 917-400-3011
archasbuilt@gmail.com
www.archasbuilt.com

DATE:	11/30/17
SURVEYED BY:	IBRAHIM SMATI
PROJECT NO:	17.1130
SCALE:	N.T.S
SHEET TITLE:	

EXISTING SPRINKLER
SYSTEM SEURVEY NOTE

SHEET NO: